


20

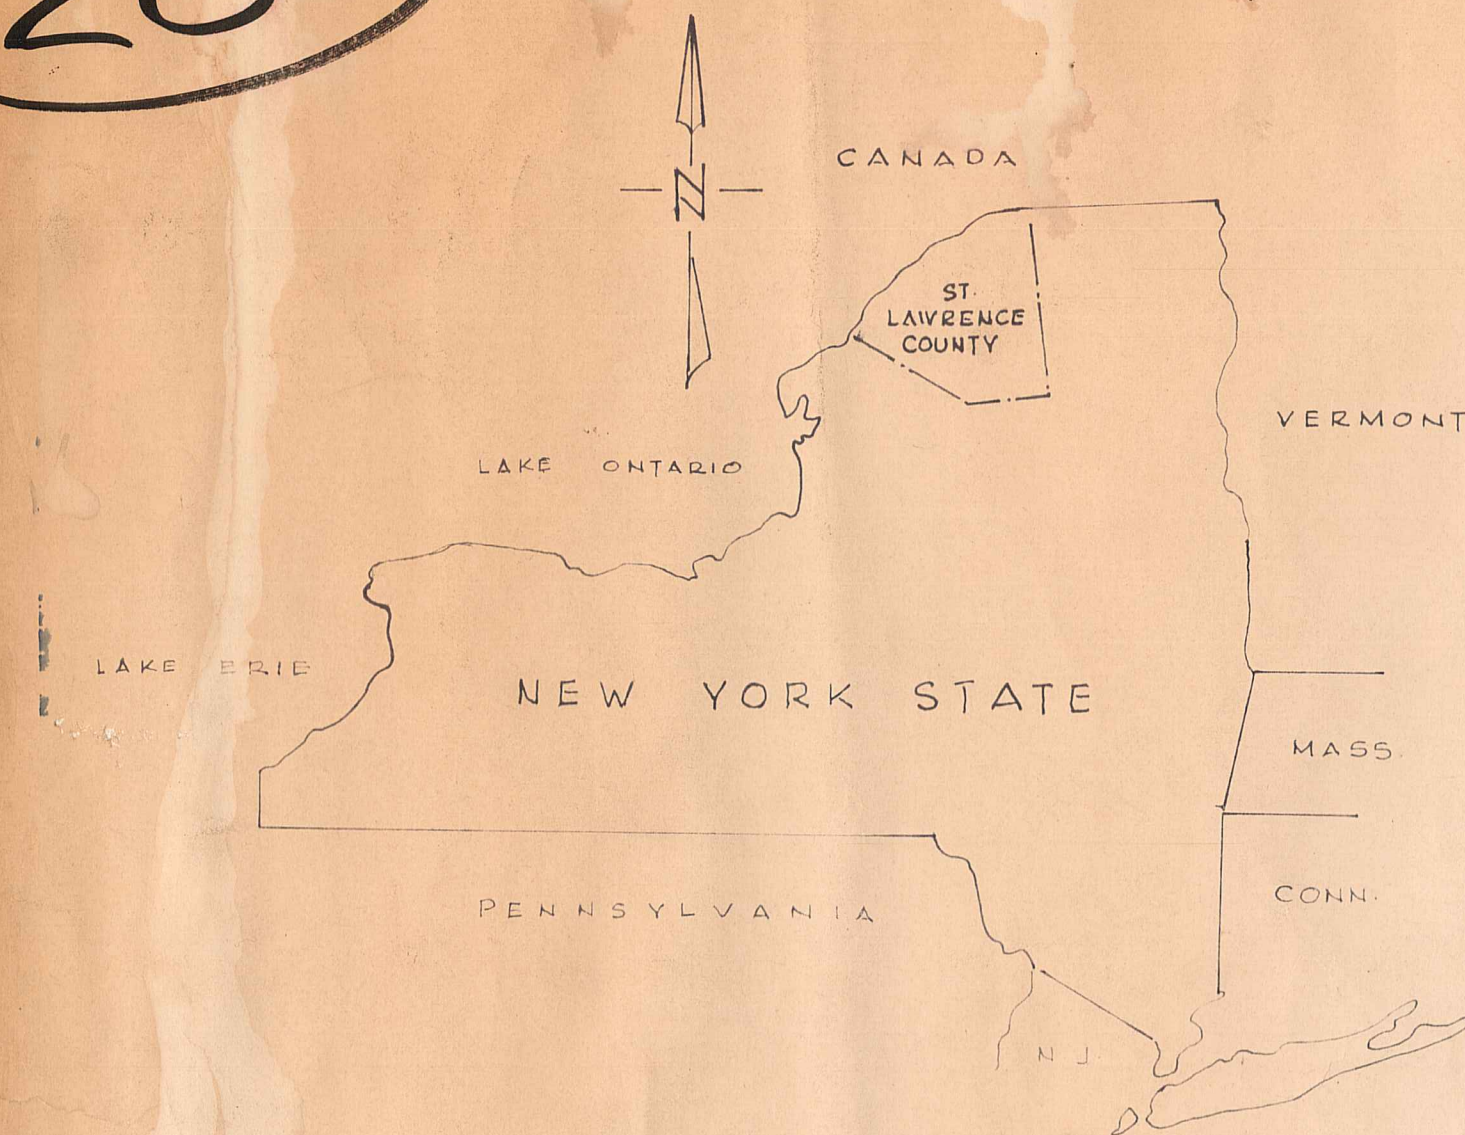

VICINITY MAP



LOCATION PLAN

TOWN OF CANTON HIGHWAY DEPARTMENT GARAGE

TOWN OF CANTON, ST LAWRENCE COUNTY, NEW YORK

CONTRACT DRAWINGS

LIST OF DRAWINGS

Sheet No.	Description
CONTRACT NO. 1	
1	TITLE SHEET
A-1	SITE PLAN & DETAILS
A-2	FLOOR PLANS & DETAILS
A-3	ELEVATIONS
A-4	WALL SECTIONS & DETAILS
A-5	DOOR SCHEDULE & DETAILS
A-6	FOUNDATION PLAN & SECTIONS
S-1	FRAMING PLAN & SECTIONS
CONTRACT NO. 2	
E-1	ELECTRICAL PLANS & DETAILS
CONTRACT NO. 3	
HV-1	HEATING & VENTILATING
CONTRACT NO. 4	
P-1	PLUMBING PLANS & DETAILS

TOWN BOARD

TOWN SUPERVISOR
HAROLD SMITH

COUNCILMAN ----- PHILIP McMASTERS
TOWN JUSTICE ----- JOHN MOORE
TOWN JUSTICE ----- JOHN OLIVER
TOWN CLERK ----- NADINE LONGSHORE

SUPERINTENDENT OF HIGHWAYS
PHILLIP REXFORD

Prepared by
AKINS ASSOCIATES
CONSULTING ENGINEERS

[Signature]
PROFESSIONAL ENGINEERS' LICENSE NO. 27467

